
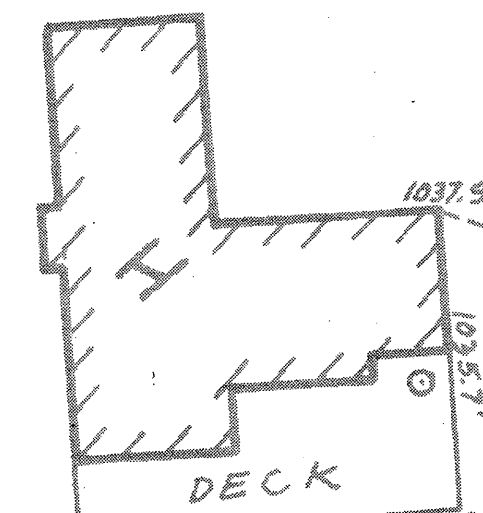


77

75

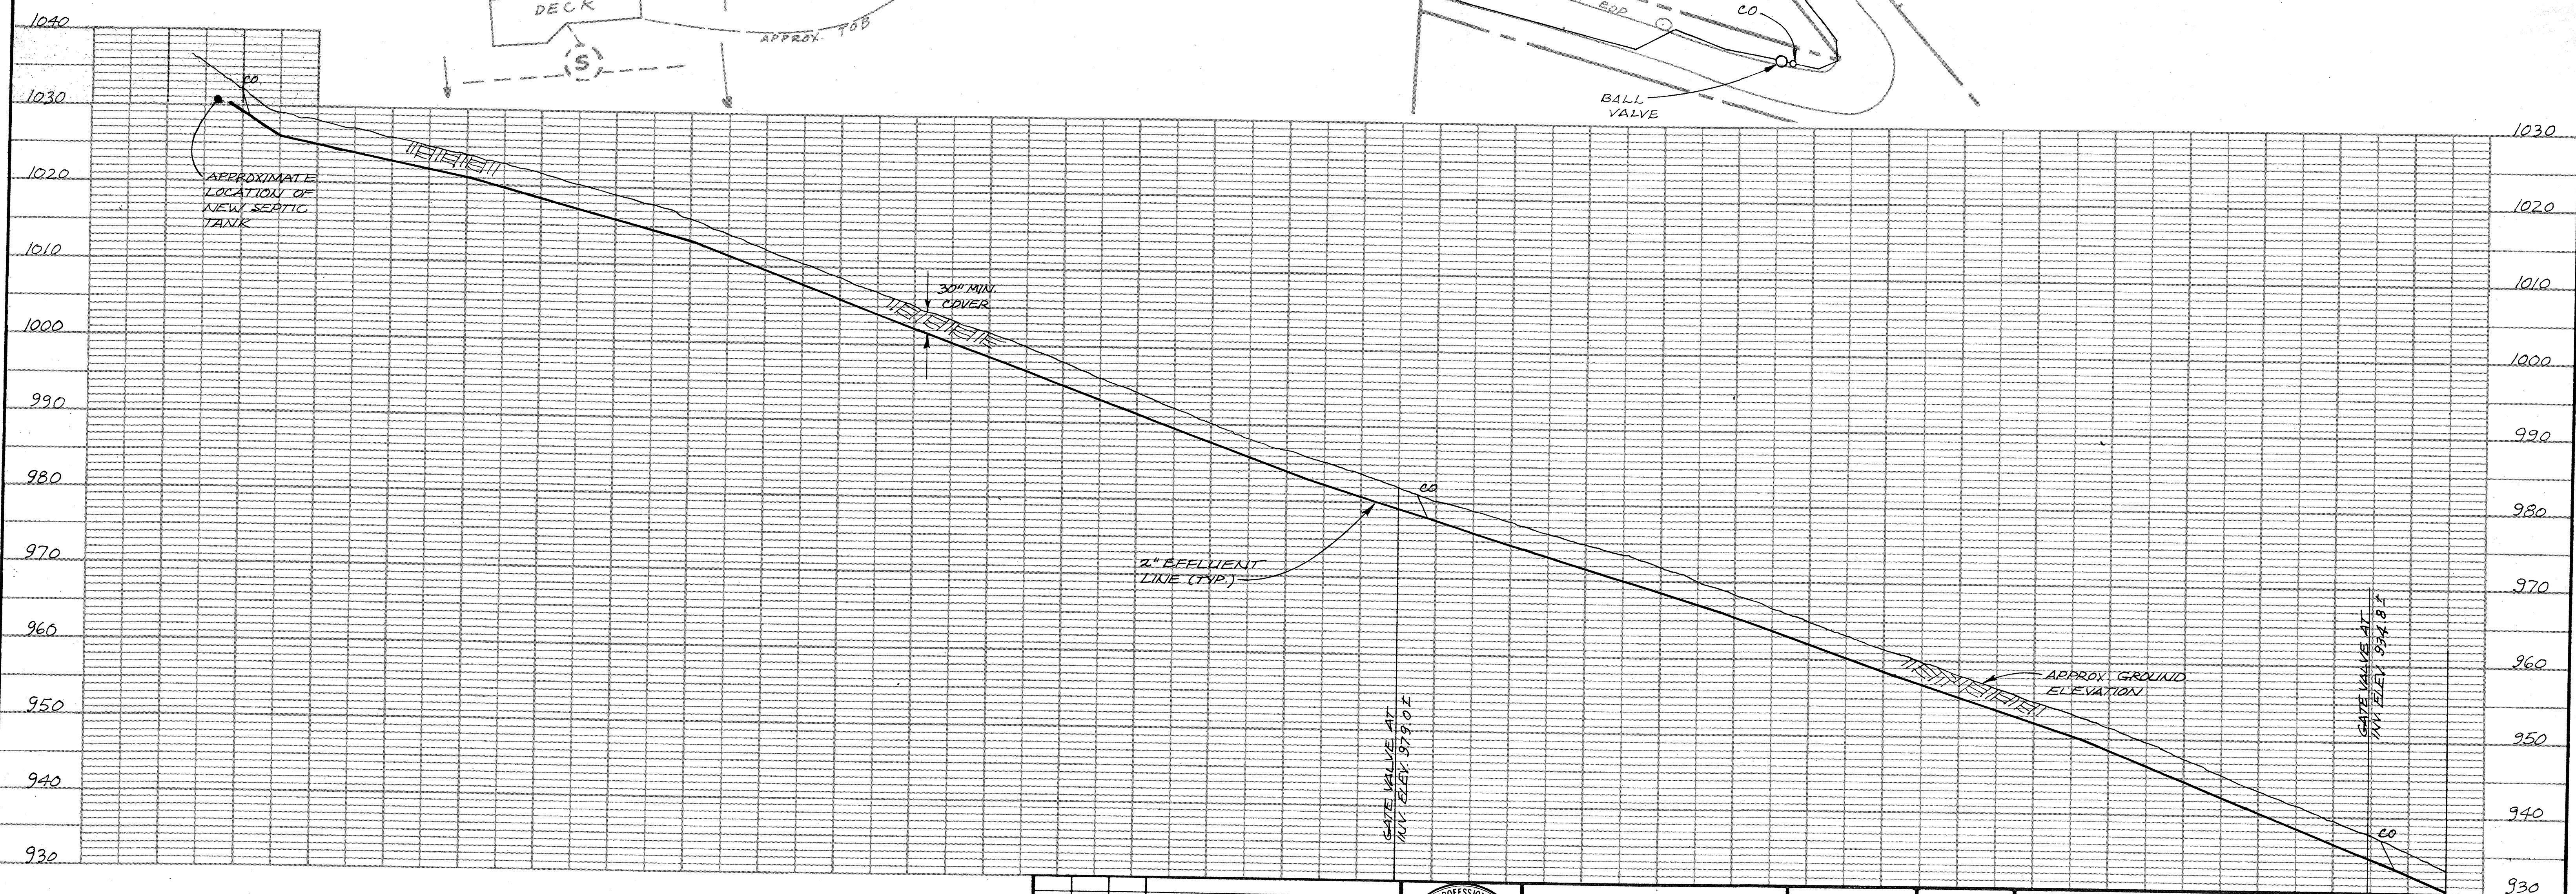

PARKING

GARDEN AREA

TO WATER STORAGE TANKS

MATCHLINE WITH SHEET A1

BALL VALVE

BALL VALVE

2" PVC SERVICE LATERAL

APPROX. EOP

BALL VALVE

APPROXIMATE LOCATION OF NEW SEPTIC TANK

30" MIN. COVER


2" EFFLUENT LINE (TYP.)

APPROX. GROUND ELEVATION

GATE VALVE AT INV. ELEV. 994.83'

GATE VALVE AT INV. ELEV. 979.01'

REV.	DATE	BY	DESCRIPTION

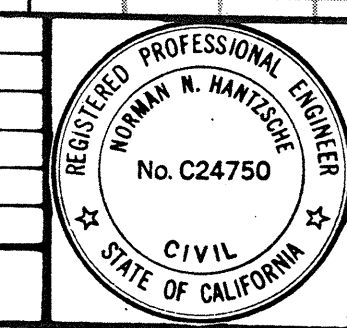

**Questa Engineering Corporation**  
 CIVIL ENVIRONMENTAL & AGRICULTURAL ENGINEERS  
 1220 BRICKYARD COVE ROAD  
 POINT RICHMOND, CALIFORNIA 94807

DESIGN:	NH/RM	DATE	10/94
DRAWN:	SD		
CHK'D:	NH		
APPV'D:			

**SCALE**  
 PLAN: 1" = 20'  
 PROFILE: Horizontal: 1" = 20'  
 Vertical: 1" = 10'

LAKE CANYON COMMUNITY SERVICES DISTRICT  
 COMMUNITY WASTEWATER PROJECT  
**PLAN AND PROFILE**  
**(A LINE)**

JOB NO.  
92158  
 SHEET  
**A9**